


FW - DENOTES FLOOR WASTE
 WH - DENOTES WATER HEATER
 AC - DENOTES AIR CONDITIONING UNIT

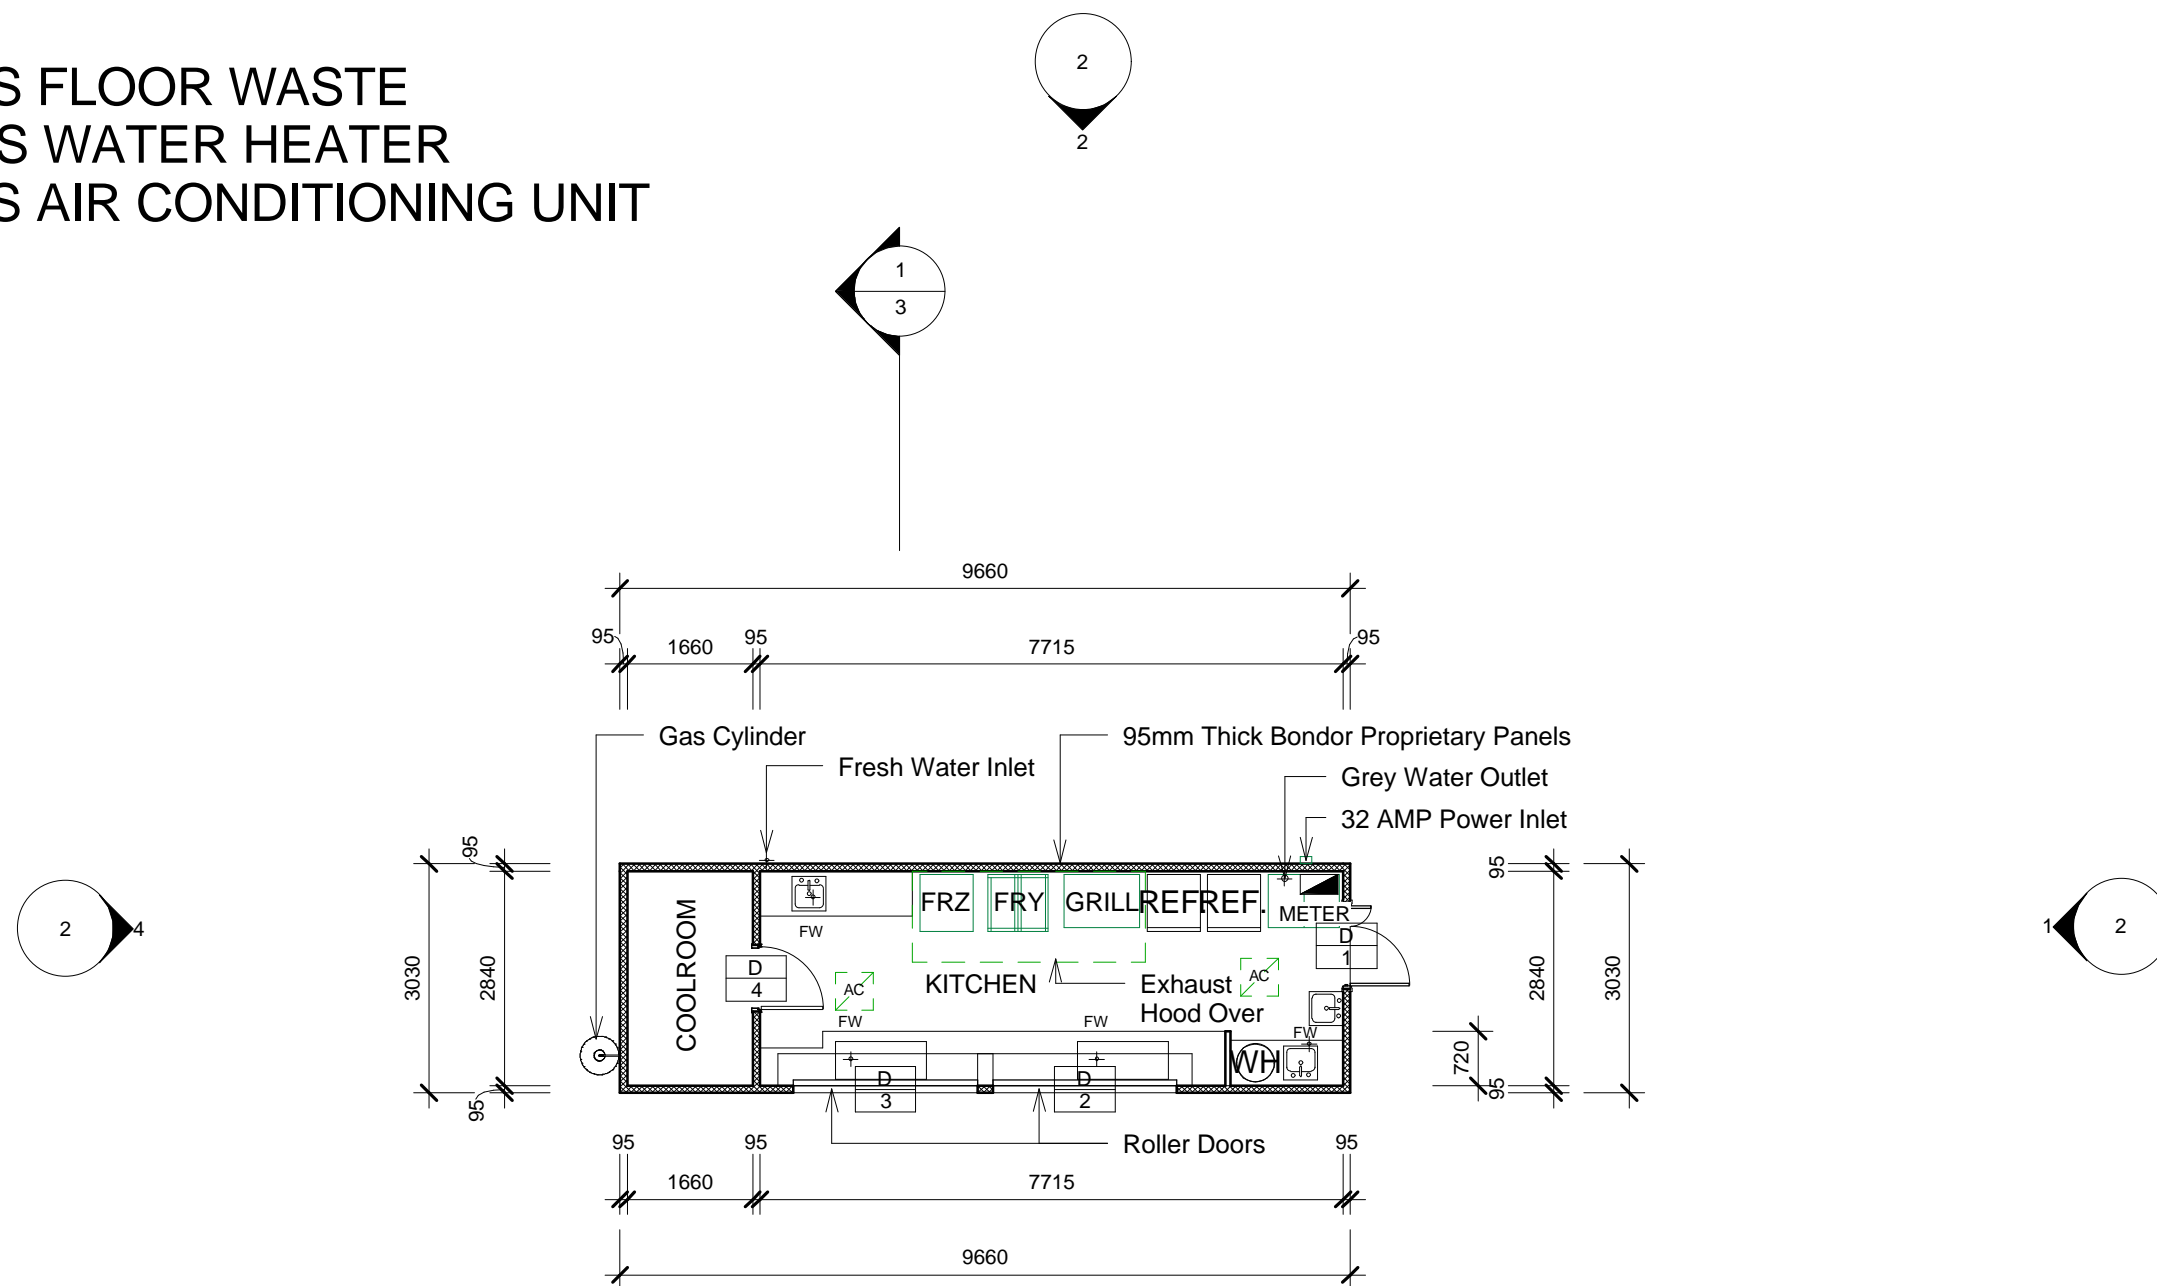

1 Floor Plan
 1 : 100

GENERAL NOTES: <small>ALL DIMENSIONS TO BE CHECKED ON SITE BY BUILDER BEFORE COMMENCEMENT OF ANY WORK. NOTED DIMENSIONS ARE TO AT ALL TIMES TAKE PRECEDENCE OVER SCALING. THE BUILDING CODE OF AUSTRALIA & ALL RELEVANT AMENDMENTS & UPDATES AS WELL AS THE S.A. A. CODES SHALL AT ALL TIMES BE THE MINIMUM STANDARDS OF COMPLIANCE. CHECK COUNCIL APPROVED & STAMPED PLANS TO ENSURE COMPLIANCE WITH ALL CONDITIONS. COPYRIGHT REMAINS THE PROPERTY OF LEON TOLLEMACHE DESIGN</small>	Project: Mobile Kitchen 1	Title: Floor Plan	Client: Cheeky's Cafe & Catering	LEON TOLLEMACHE DESIGN <small>ARCHITECTURAL DESIGN & DRAFTING</small> <small>GOLD CARD DESIGNER LIC. No. 709219</small>	Scale: 1 : 100	Date: 19/02/2007 3:58:58 PM	Drawn: LTD
	Address: Tugun Desalination Plant					DWG No: 290107	Page: 1